

**SECTION 00 90 02  
BIDDING AND CONTRACT REQUIREMENTS  
ADDENDUM NUMBER (2)**

**Demonica Kemper Architects  
125 N. Halsted Street, Suite 301  
Chicago, IL 60661  
312.496.0000**

To: Prospective Bidders  
Issued: February 21, 2020

**Re: ADDENDUM NUMBER (2) TO THE BIDDING DOCUMENTS FOR**

**Illinois Valley Community College  
Building F AHU & Building J Exhaust Upgrades  
Architect's Project Number: 20-005**

This addendum forms a part of the bidding and contract documents and modifies the original bidding documents dated February 3, 2020, and Addendum 1 dated February 18, 2020. Acknowledge receipt of this addendum in the space provided on the Bid Form. FAILURE TO DO SO MAY SUBJECT BIDDER TO DISQUALIFICATION.

**ADDENDA ITEMS**

**REVISIONS TO THE DRAWINGS**

1. Drawing M2.02 – Building J Main Floor Plan – Mechanical New Work
  - a. **ADD** gas piping for grade mounted rooftop unit RT-1. See attached sheet M2.02.

**END OF SECTION 00 90 02**

**Attachments:**

1. Sheet M2.02




ARCHITECTURE:  
 DEMONICA KEMPER ARCHITECTS  
 125 N. HALSTED ST., SUITE 301  
 CHICAGO, IL 60661  
 T: 312.496.0000 F: 312.496.0001

MEP&FP ENGINEERING:  
 MILLIES ENGINEERING GROUP  
 9711 VALPARADO DRIVE, STE A, IL 60321  
 T: 219.924.8400

**SHEET NOTES**

1. SECURE THE EXTERIOR SUPPLY AND RETURN AIR DUCTWORK TO THE EXTERIOR WALL WITH ANGLE SUPPORTS COMPLETE AS REQUIRED.

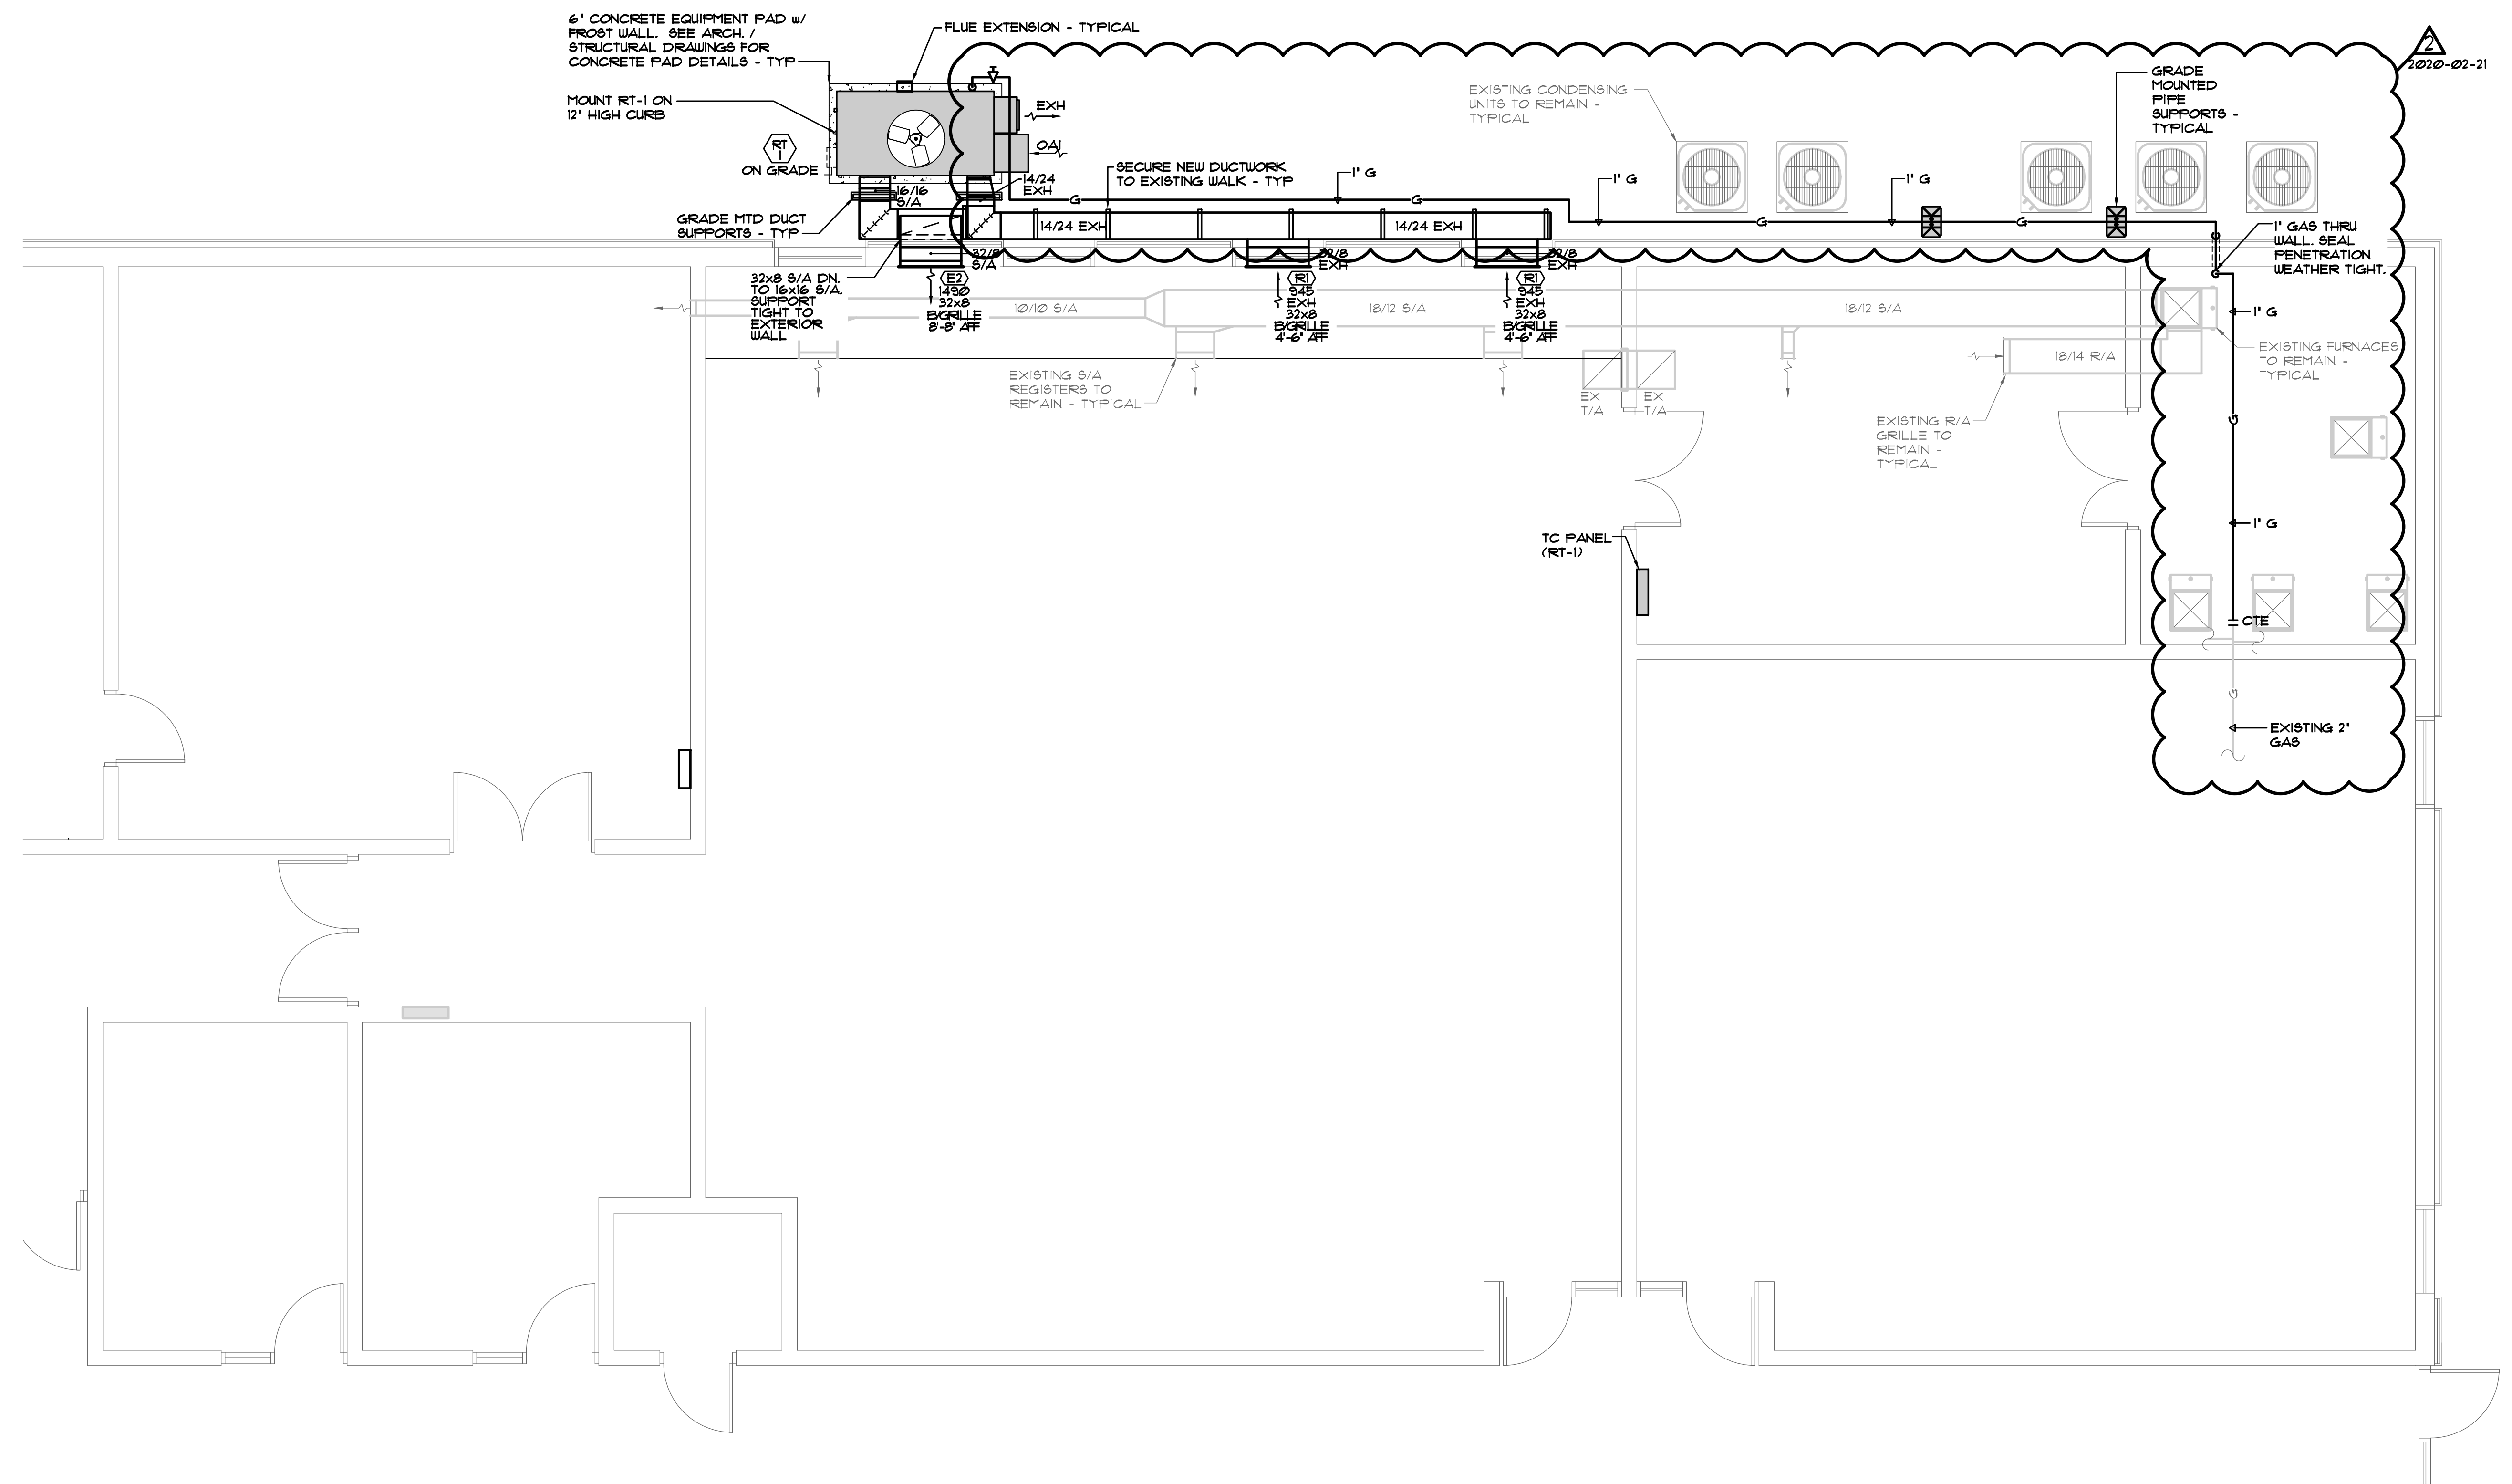

1 BUILDING 'J' MAIN FLOOR PLAN - MECHANICAL NEW WORK  
 1/4" = 1'-0"

AHU REPLACEMENT AT BUILDINGS F & J  
 ILLINOIS VALLEY COMMUNITY COLLEGE  
 815 N ORLANDO SMITH STREET  
 OGLESBY, IL 61348  
 DKA PROJECT NO: 20-005



KEY PLAN:

SHEET STATUS: 02/03/20  
**ISSUED FOR BID**

DESCRIPTION:	DATE:
▲ ADDENDUM 2	02.21.20

SHEET TITLE:  
**BUILDING 'J' MAIN FLOOR PLAN - MECHANICAL NEW WORK**

SHEET NUMBER:  
**M2.02**